


PLAN VIEW

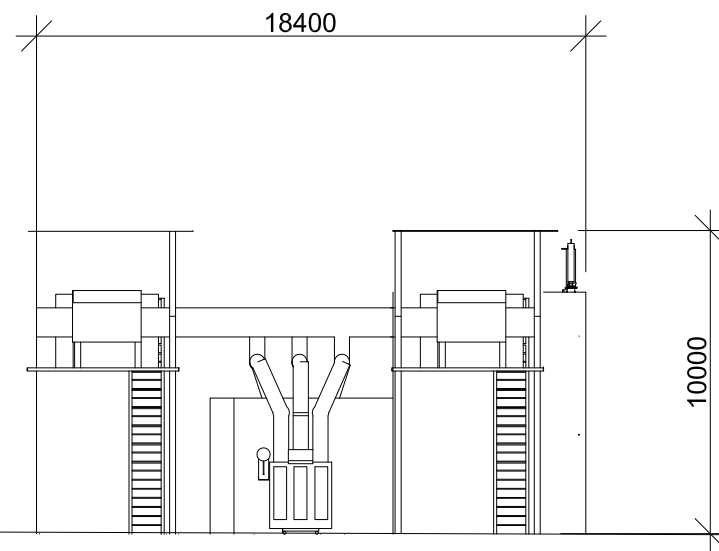

CIRCUIT BREAKER AUX TRANSFORMER CIRCUIT BREAKER

NORTH/SOUTH ELEVATION

Revisions:

Revision	Date	Revision Notes	Drawn	Inspected
01	06.07.2023	First Issue	AE	JM

LEGEND:

Project:
Necton Greener Grid Park



Statkraft UK Ltd.
 19th Floor, 22 Bishopsgate
 London, EC2N 4BG
 Tel: +44 (0) 20 7549 1000



CADmando Design & Draughting Solutions Ltd
 The Long Barn, The Courtyard, Severn Drive, Tewkesbury
 Business Park, GL20 8GD
 Tel: +44 (0) 1684 850919
 Mob: +44 (0) 7814436910

Status:
PLANNING

Drawing Title:
**Standard Details:
 Circuit Breakers & Auxiliary Transformer**

Drawn: GF	Checked: JM	First Issued: 27.03.2023
--------------	----------------	-----------------------------

Project Code: **STA002-** Drawing Number: **SD-18**

Sheet Size: A3	Scale: 1:250	01
--------------------------	------------------------	-----------

